
 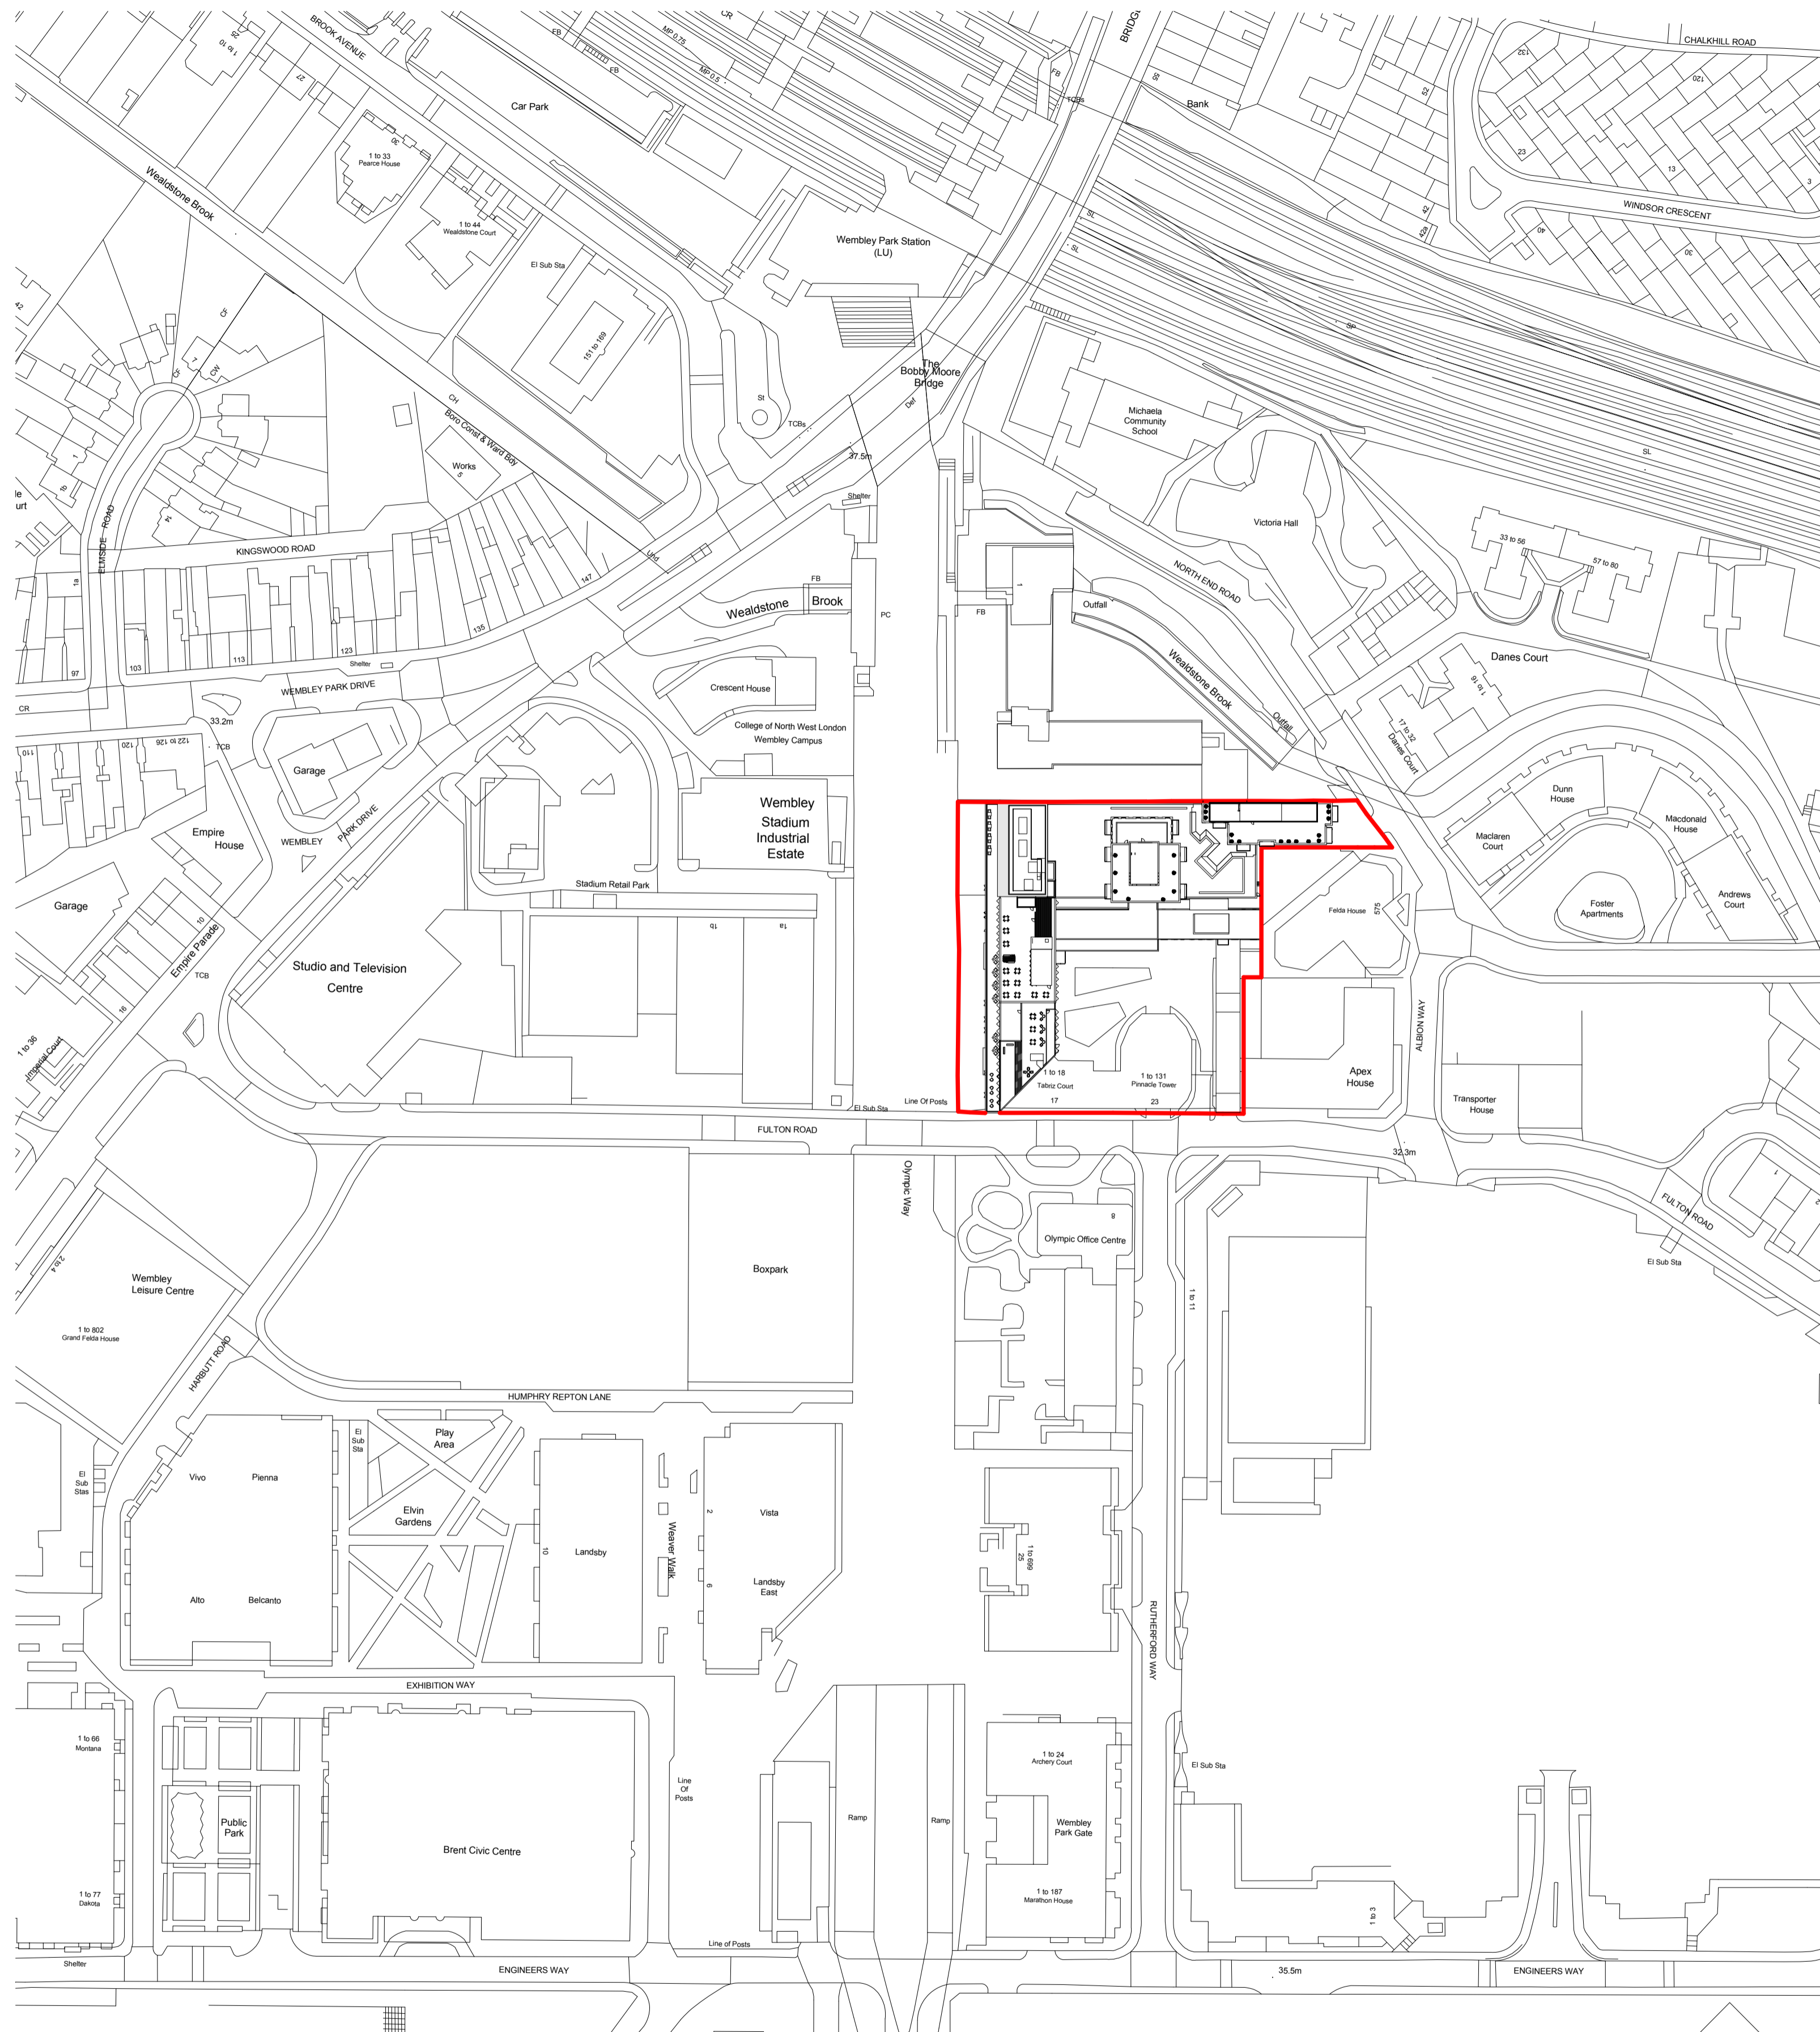


Contractors and consultants are not to scale dimensions from this drawing



Revision	Date	Drawn By	Description
A	29/01/21		Planning - Issue

BroadwayMalyan^{BM}

4 Pear Place
London
SE1 8BT

T: +44 (0)20 7261 4200
F: +44 (0)20 7261 4300
E: Lon@BroadwayMalyan.com

www.BroadwayMalyan.com

Client
Hycgan Ltd
Project
**Olympic Way
3-5 Olympic Way, Wembley**
Description
Site Plan - Proposed

Status	Revision
For Information	A
Scale	Author
1:200@A1	29/01/21
Job Number	Drawing Number
34597	OLY-BMA-XX-20-DR-A-PL-01-020

Original size 100mm @ A1 Copyright Broadway Malyan Limited

1 Site Plan - Proposed

Scale 1 : 1250